



- NOTE:
1. ALL REFRIGERANT PIPE SHALL RUN INSIDE SECOND FLOOR CEILING.
 2. PIPE RISER HEIGHT FOR FLOOR MOUNTED UNITS IS 4.00 METERS
 3. INSTALLATION OF AIR DISCHARGE METAL DEFLECTOR TO THE OUTDOOR UNITS IF NECESSARY

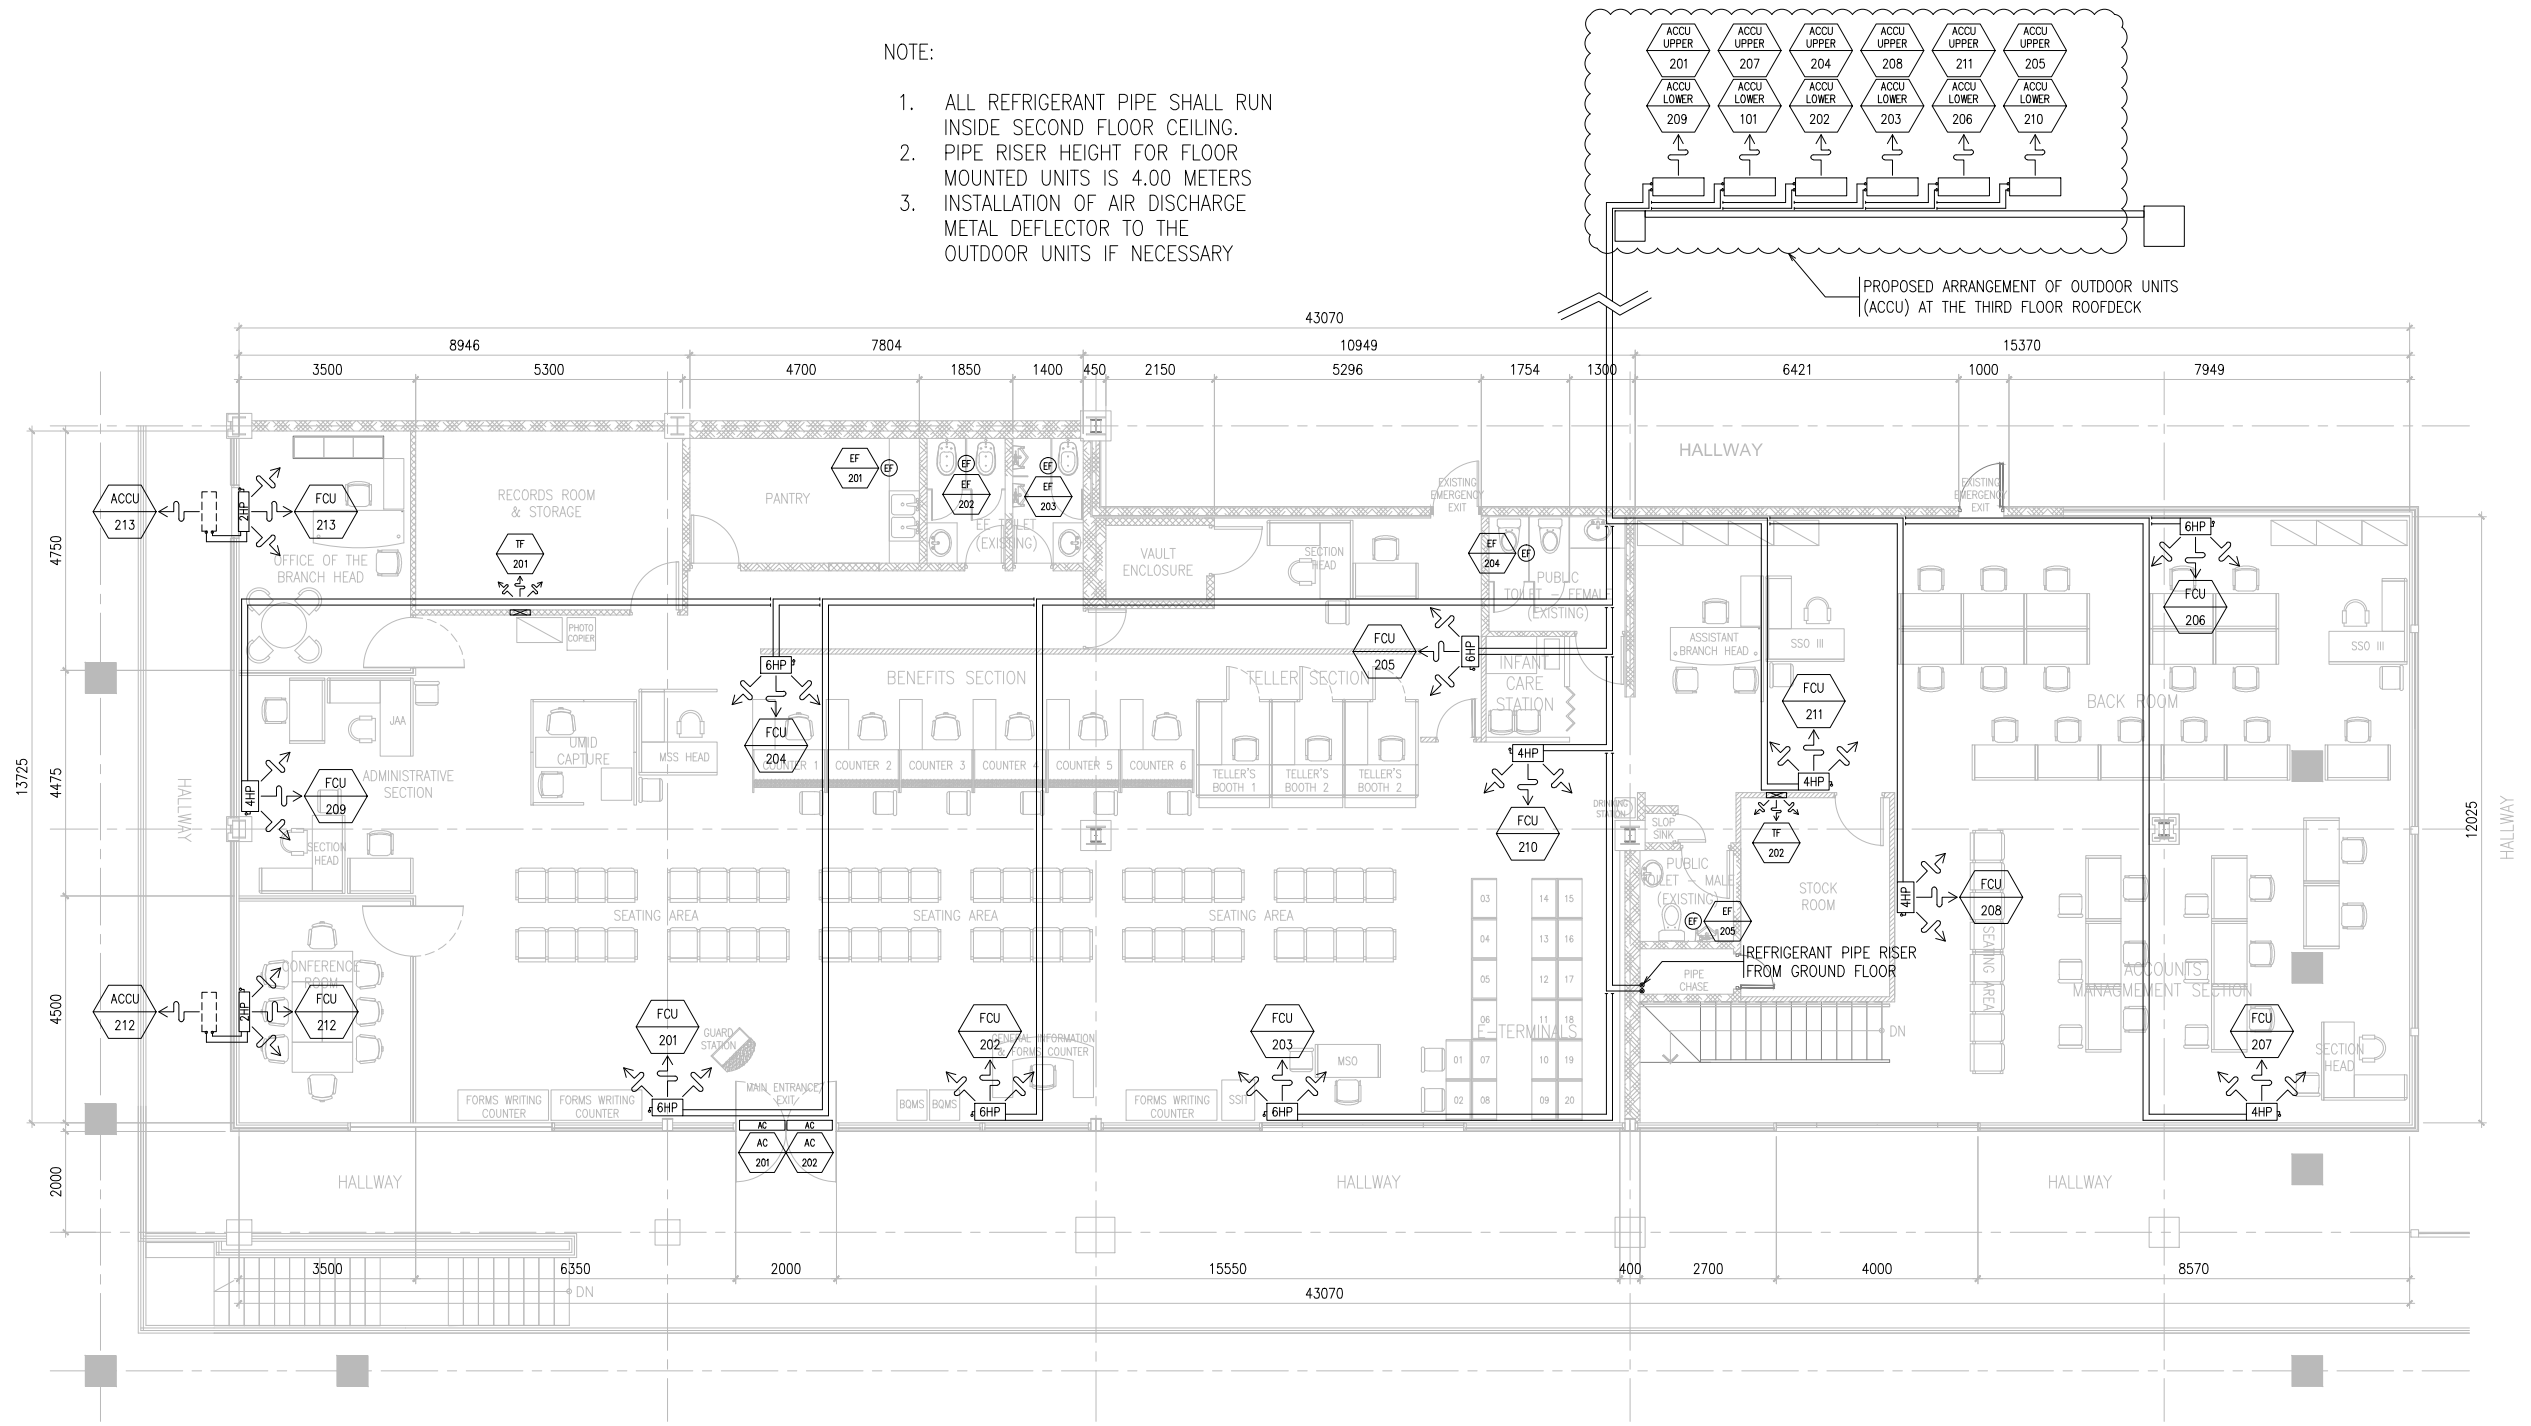

PARTIAL SECOND FLOOR PROPOSED MECHANICAL LAYOUT

1
M-04 SCALE 1:150

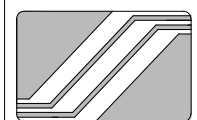

SOCIAL SECURITY SYSTEM

ENGINEERING AND FACILITIES MANAGEMENT DEPARTMENT

PROJECT TITLE: <h3 style="text-align: center;">PROPOSED RELOCATION OF SSS PASAY - ROXAS BRANCH</h3>	RECOMMENDING APPROVAL: STEPHEN P. YAP ACTING HEAD - EFMD	APPROVED BY: HYDEE R. RAQUID ACTING HEAD - GSD	APPROVED AS USER/OWNER: MARIA RITA S. AGUJA CONCURRENT ACTING HEAD NCR OPERATIONS GROUP	APPROVED FOR IMPLEMENTATION: JOHNSY L. MANGUNDAYAO ACTING HEAD - ADMINISTRATION GROUP	ENGINEERING TEAM DESIGNED & DRAWN BY: Antonio V. Trinos, Jr - Sr. Engr, EMT-1 REVIEWED & CHECKED BY: George N. Carreon - SSO V, EMT - 1	SHEET CONTENT: PARTIAL SECOND FLOOR PROPOSED MECHANICAL LAYOUT	ALL DRAWINGS MUST BE VERIFIED ON SITE BY THE CONTRACTOR. ALL DISCREPANCIES SHOULD BE REPORTED IMMEDIATELY TO THE ARCHITECT AND PROJECT MANAGERS. CONTRACTORS ARE TO PREPARE AND SUBMIT SHOP DRAWINGS TO THE ARCHITECT PRIOR TO COMMENCEMENT OF WORKS.	SHEET NO. <h2 style="text-align: center;">M-04</h2> DATE: April 22, 2021
LOCATION: Seascape Village, Atang Dela Rama cor. Zoilo Hilario St., CCP Complex Brgy. 076, Pasay City								